



2 First Floor Existing  
A3 Scale: 1" = 10'-0"

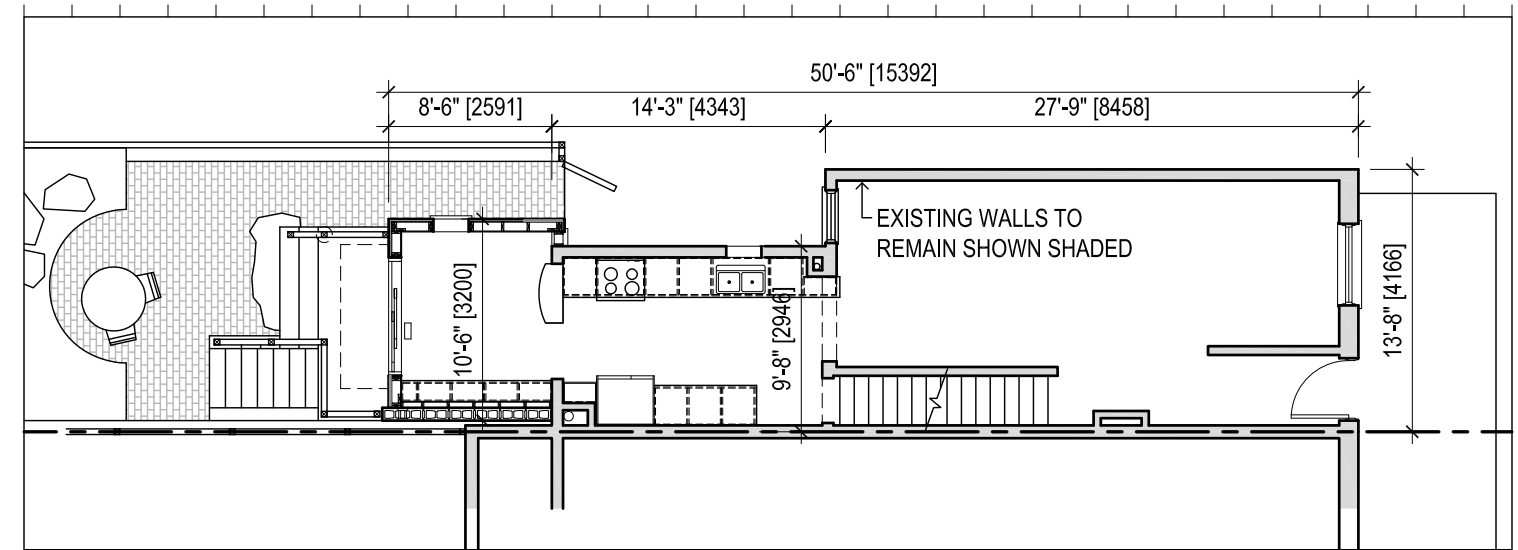

3 First Floor Proposed  
A3 Scale: 1" = 10'-0"

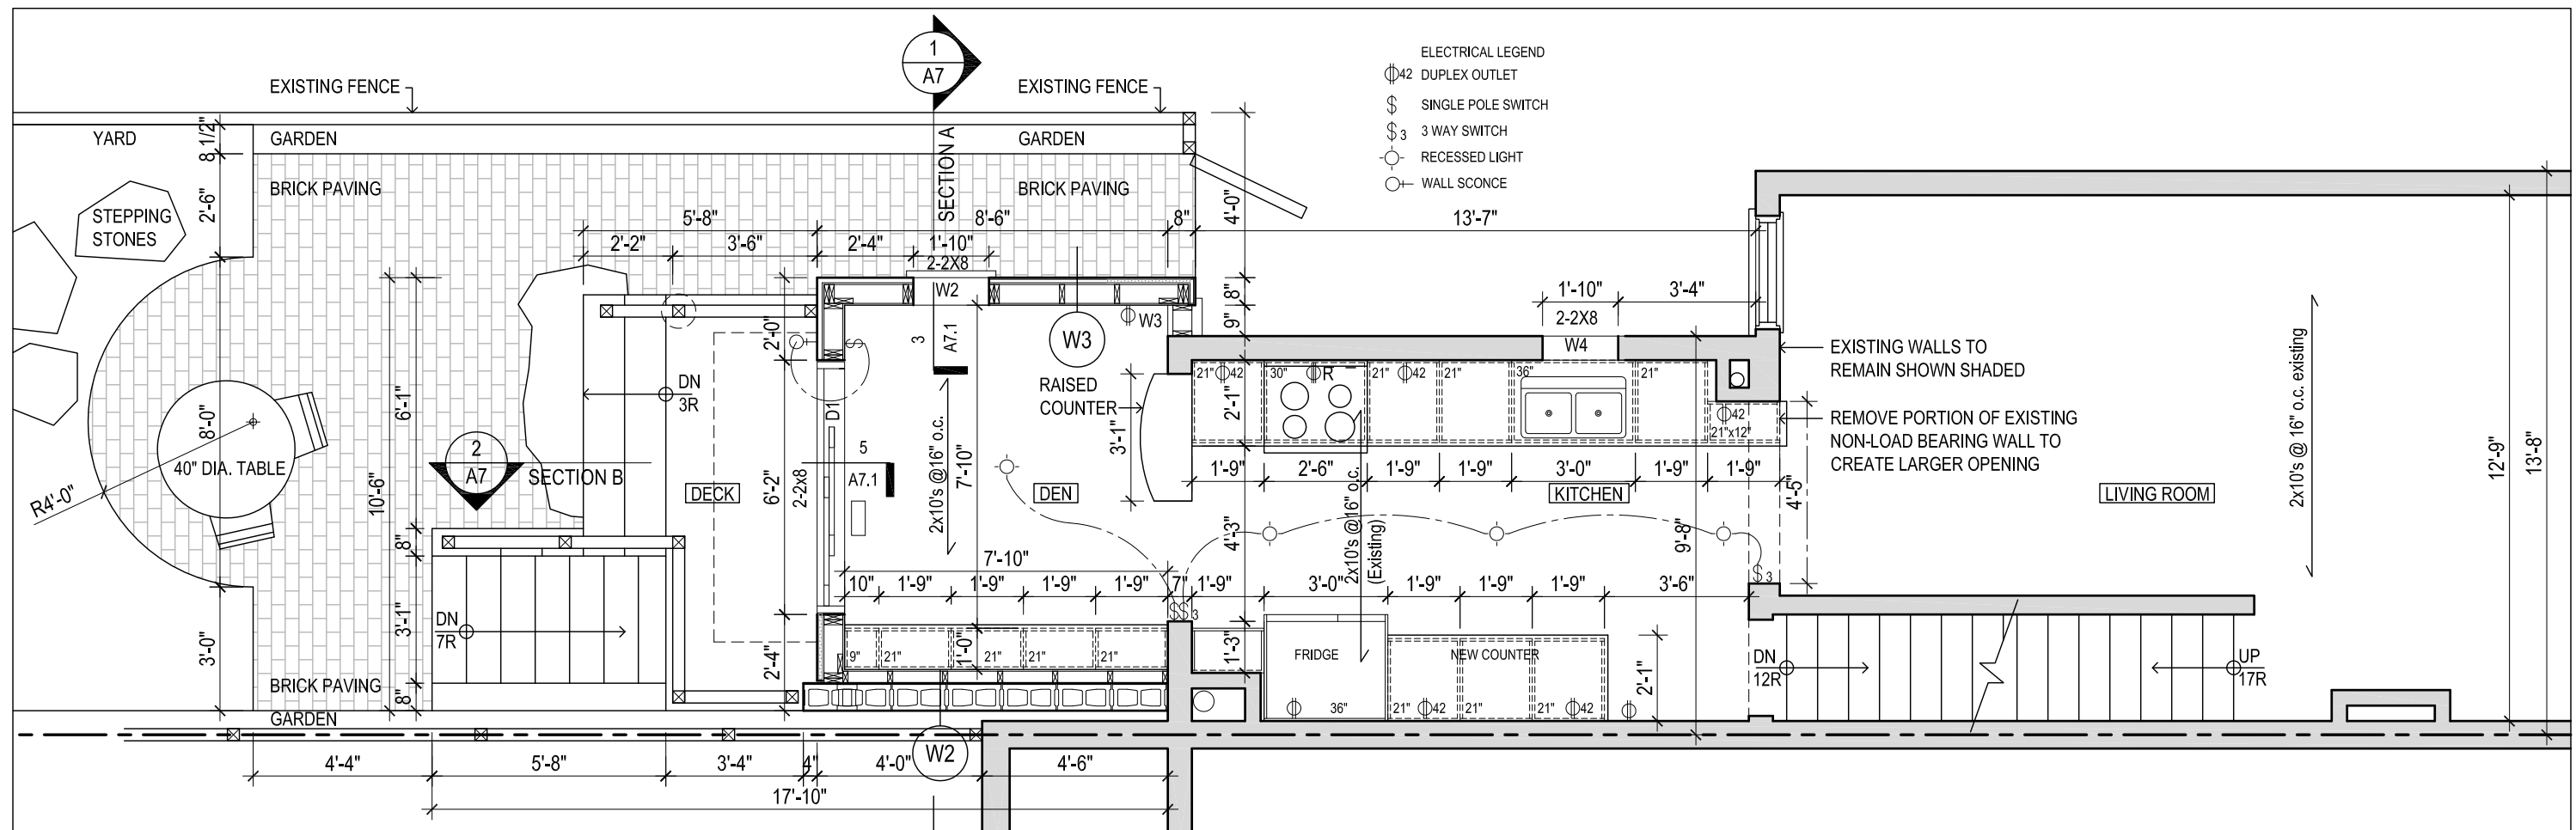

1 First Floor Plan  
A3 Scale: 1/4" = 1'-0"

- ELECTRICAL LEGEND
- ⊕42 DUPLEX OUTLET
  - \$ SINGLE POLE SWITCH
  - \$3 3 WAY SWITCH
  - RECESSED LIGHT
  - WALL SCONCE

FIRST FLOOR PLAN



**John Boone ARCHITECT**

51 Arundel Avenue, Toronto, Ontario, M4K 3A3  
Tel: 416 469 3264 Email: johnboone@rogers.com

This drawing is the Property of John Boone Architect and may be used for this project only. Scale from drawings for reference only. Dimensions to be checked and verified by the contractor on site.

198 PAPE AVENUE  
Toronto, Ontario

DRAWING SCALE 1/4" = 1'-0"  
PROJECT DATE MAY 2012  
PROJECT NUMBER 12A07  
DRAWN BY jb

PLOT DATE : January 28, 2013

No.	DATE	DESCRIPTION
3	Jan 28, 2013	Submitted for Building Permit
2	Dec 20, 2012	Submitted for Preliminary Review
1	May 30, 2012	Base Drawings Completed

**A3**